



VICINITY MAP

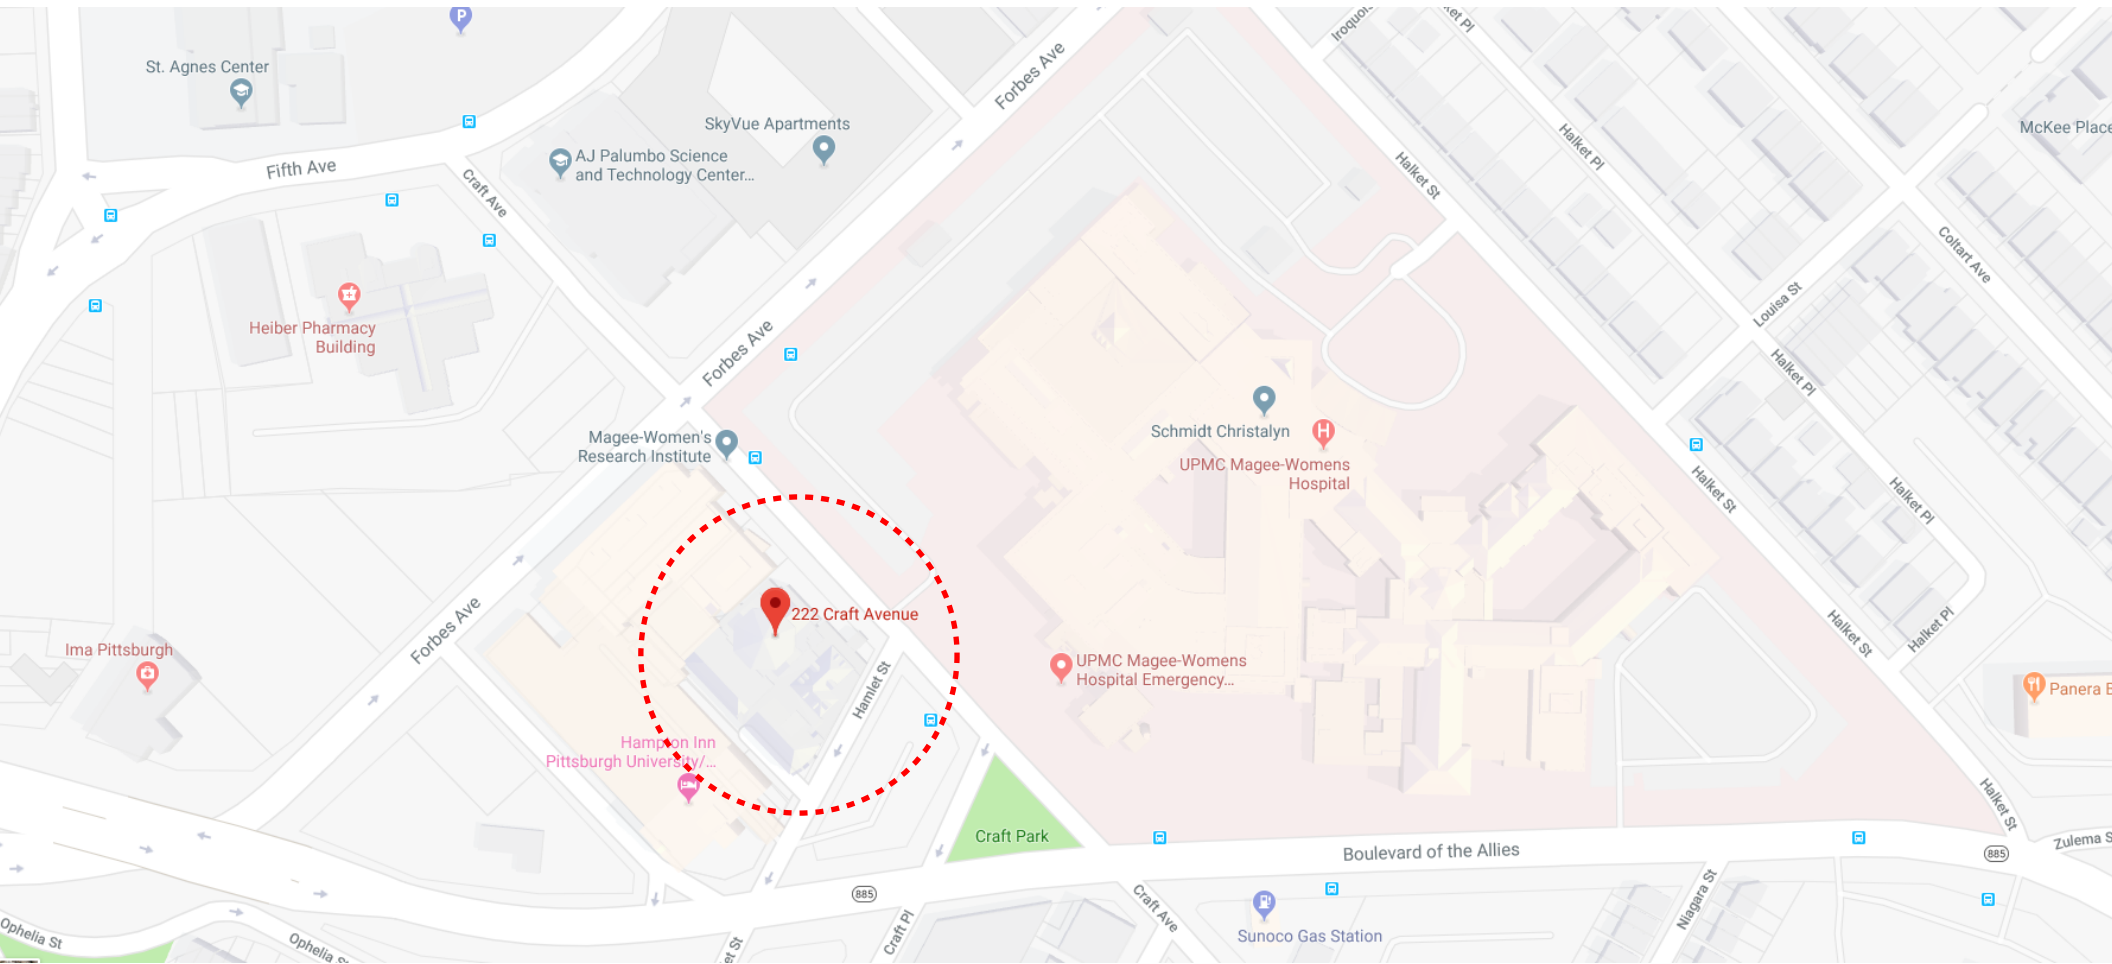

SITE MAP

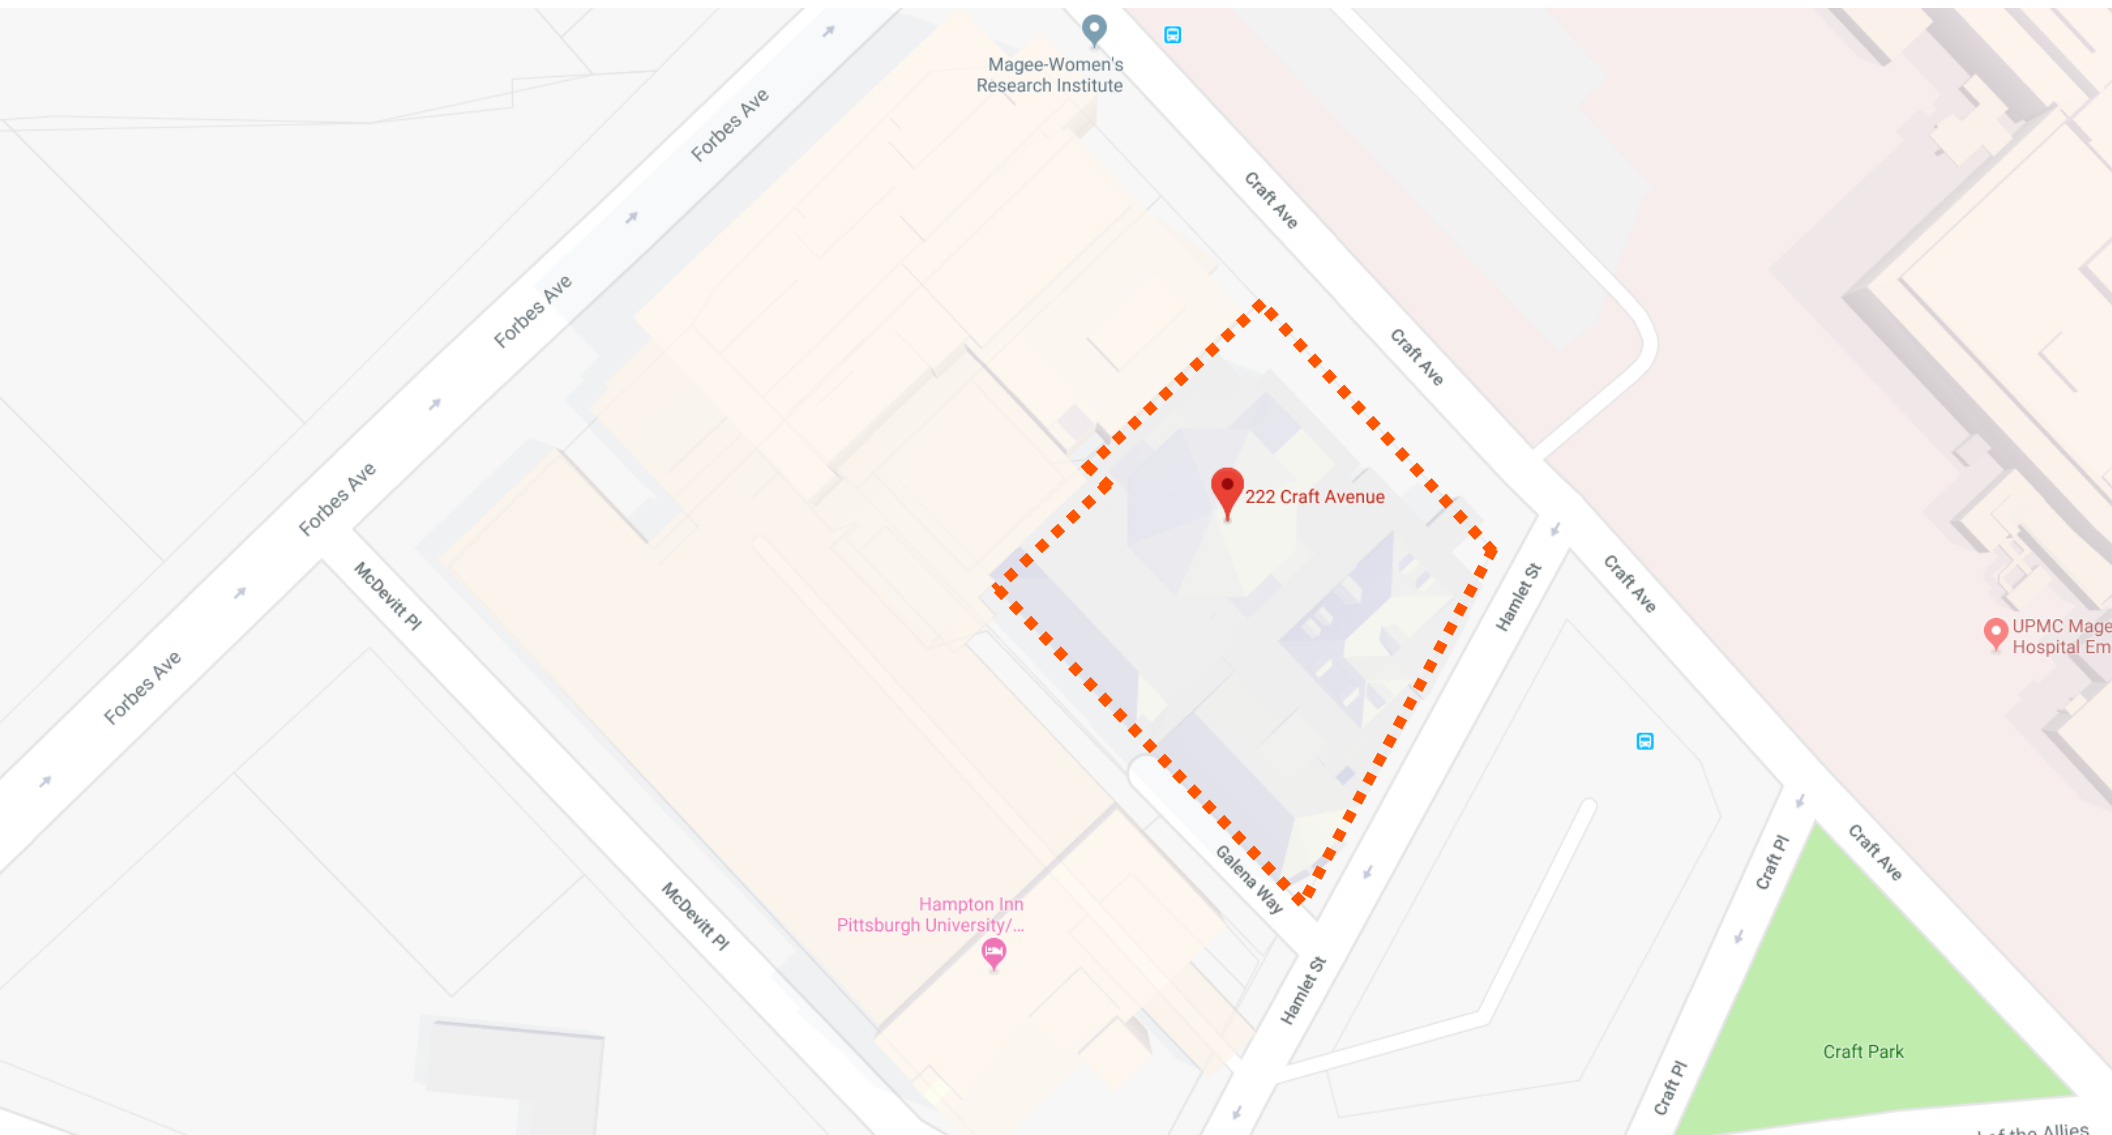

SITE PLAN



AERIAL VIEW




CRAFT AVENUE (looking south east)



CRAFT AVENUE (looking north west)




HAMLET STRET (looking north east)

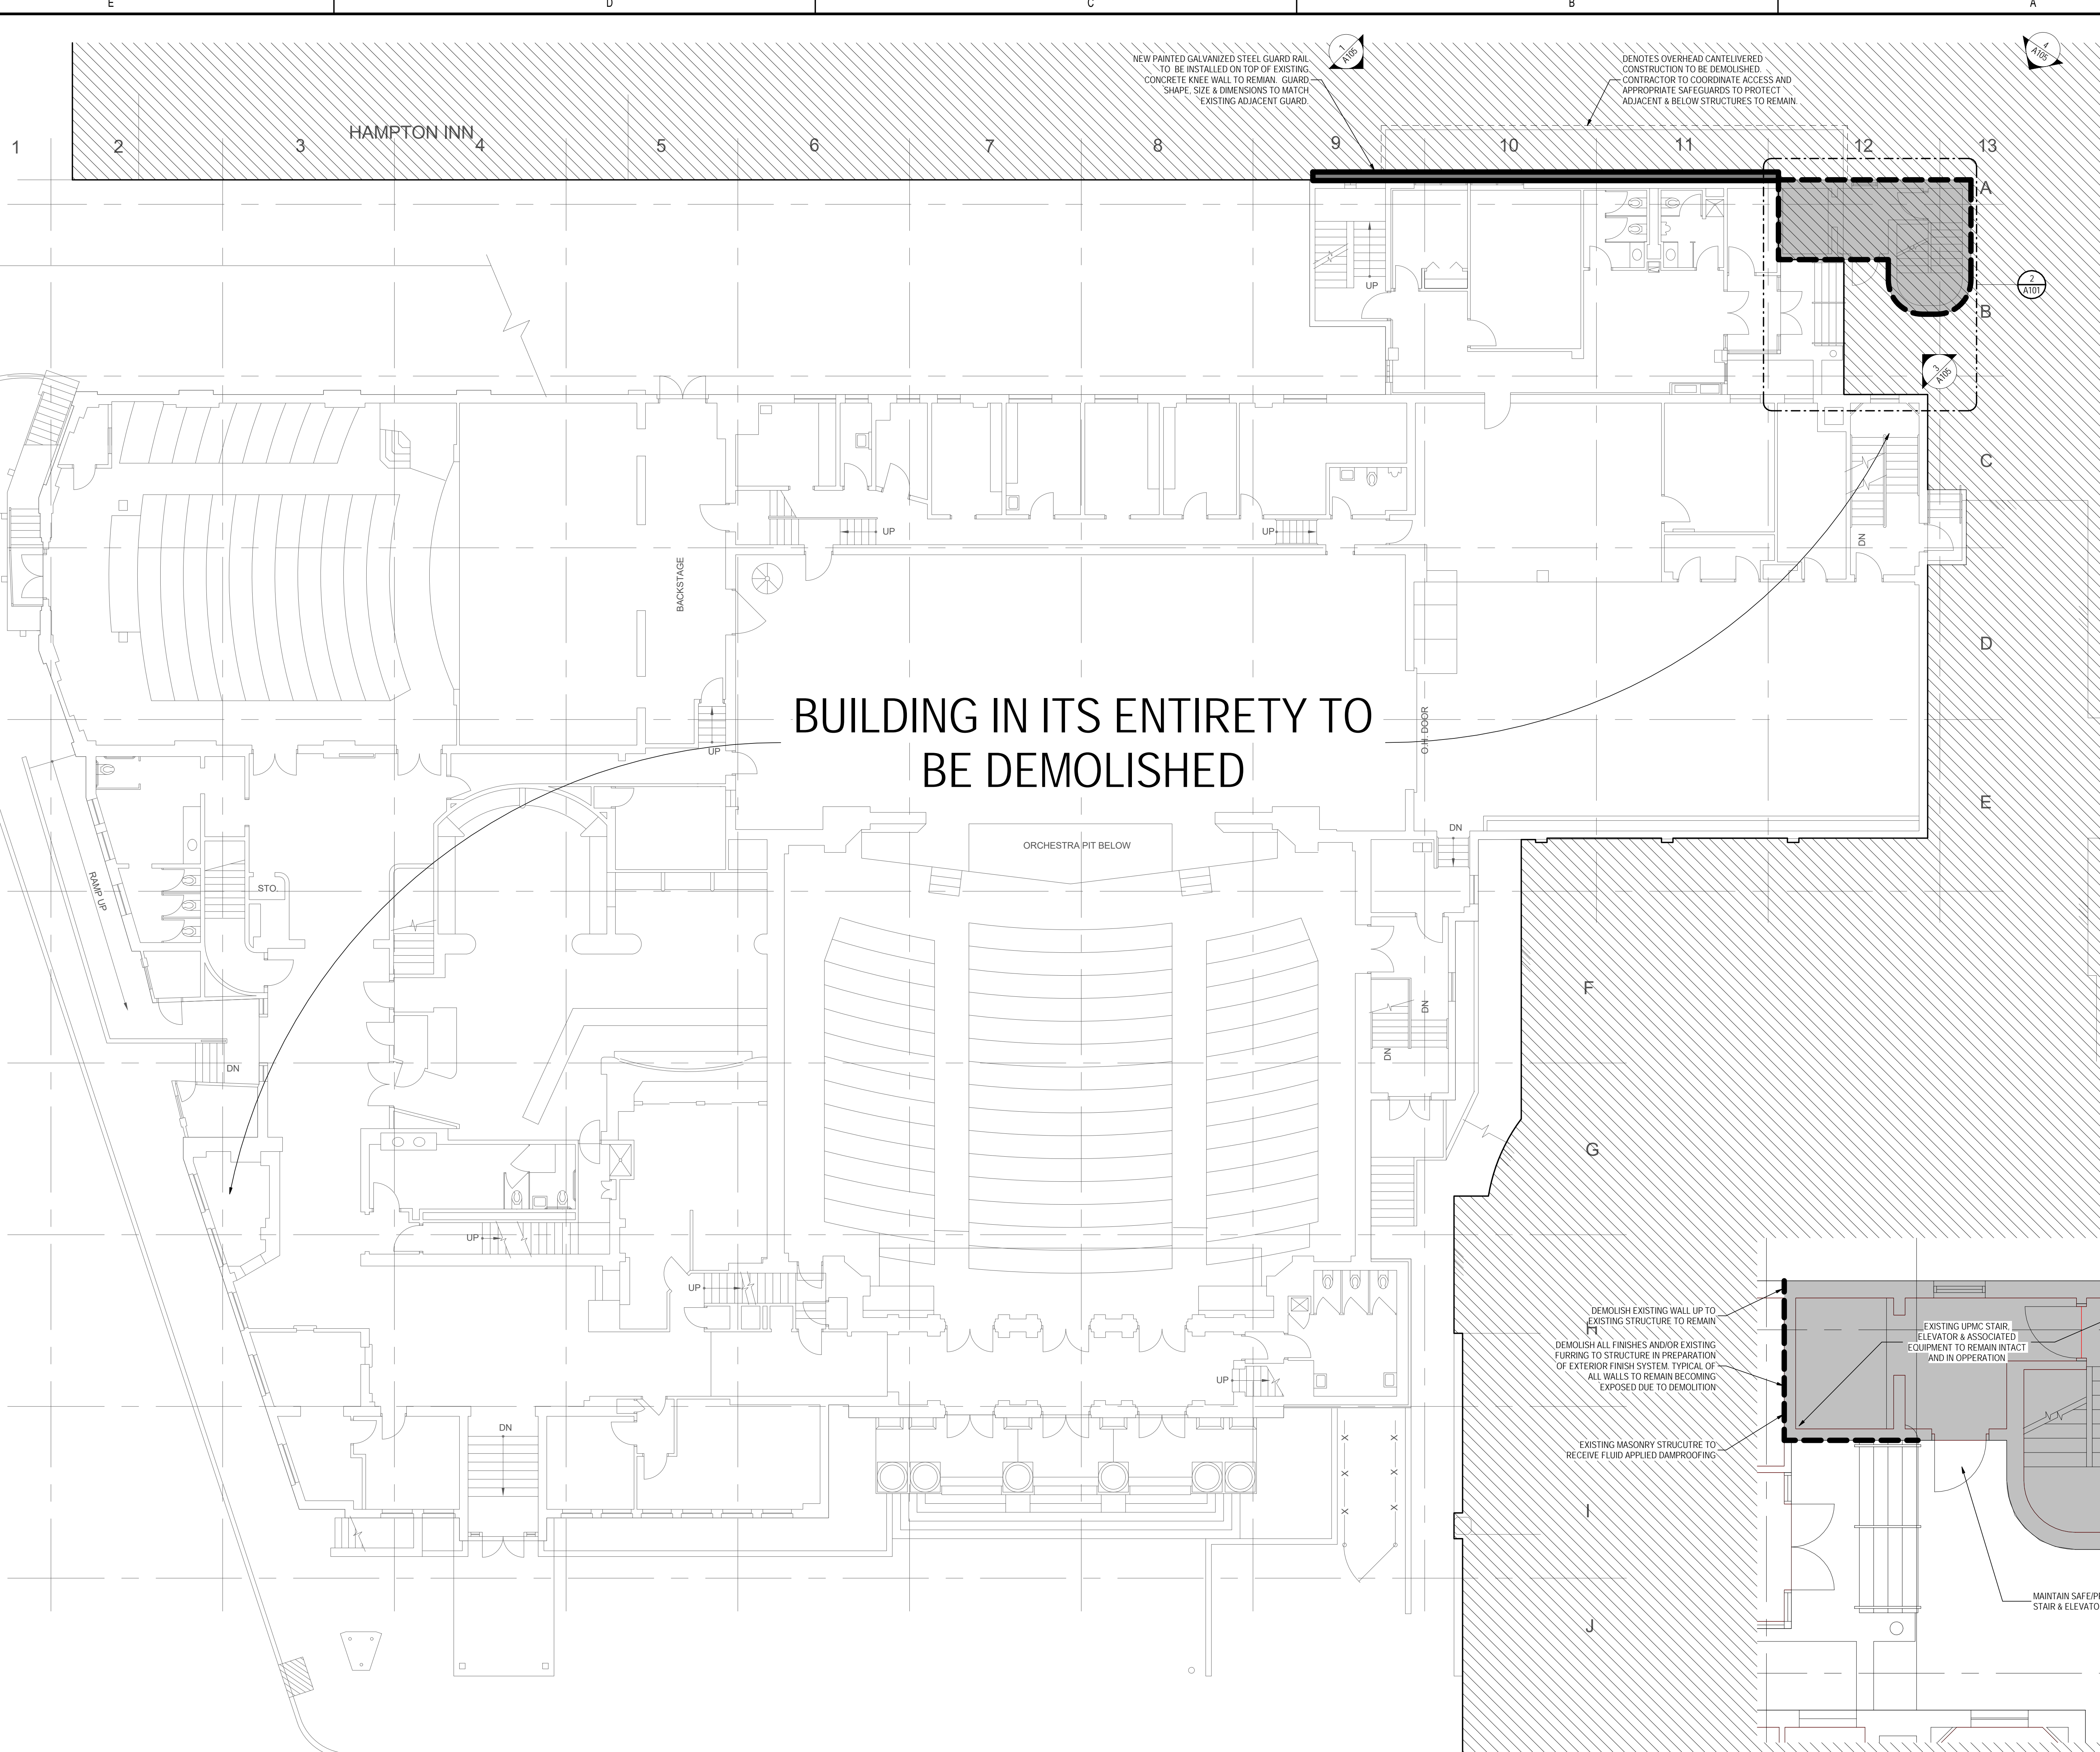

1 LEVEL 1 DEMO PLAN
 A101 1/8" = 1'-0"

HATCH LEGEND

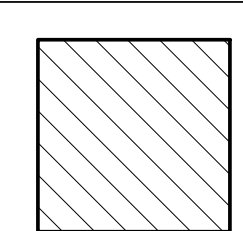

NOT IN SCOPE

2 BASEMENT DEMO PLAN - Callout 2
 A101 1/4" = 1'-0"

Revision	By	Appd	YYYYMMDD
PACKAGE G			
PACKAGE F			
PACKAGE E			
PACKAGE D			
PACKAGE C			
PACKAGE B			
PACKAGE A			
Issued			

**PRELIMINARY
 NOT FOR CONSTRUCTION**
 Not for permits, pricing or other official purposes.
 This document has not been completed or checked and
 is for general information or comment only.


Point Park University
 PLAYHOUSE DEMOLITION
 222 Craft Ave., Pittsburgh PA 15213
 Title
 FIRST FLOOR

Project No. 218011316
 Scale As indicated
 Revision Drawing No.


A101




1 VIEW OF CANTELIEVER
 A105 1/4" = 1'-0"

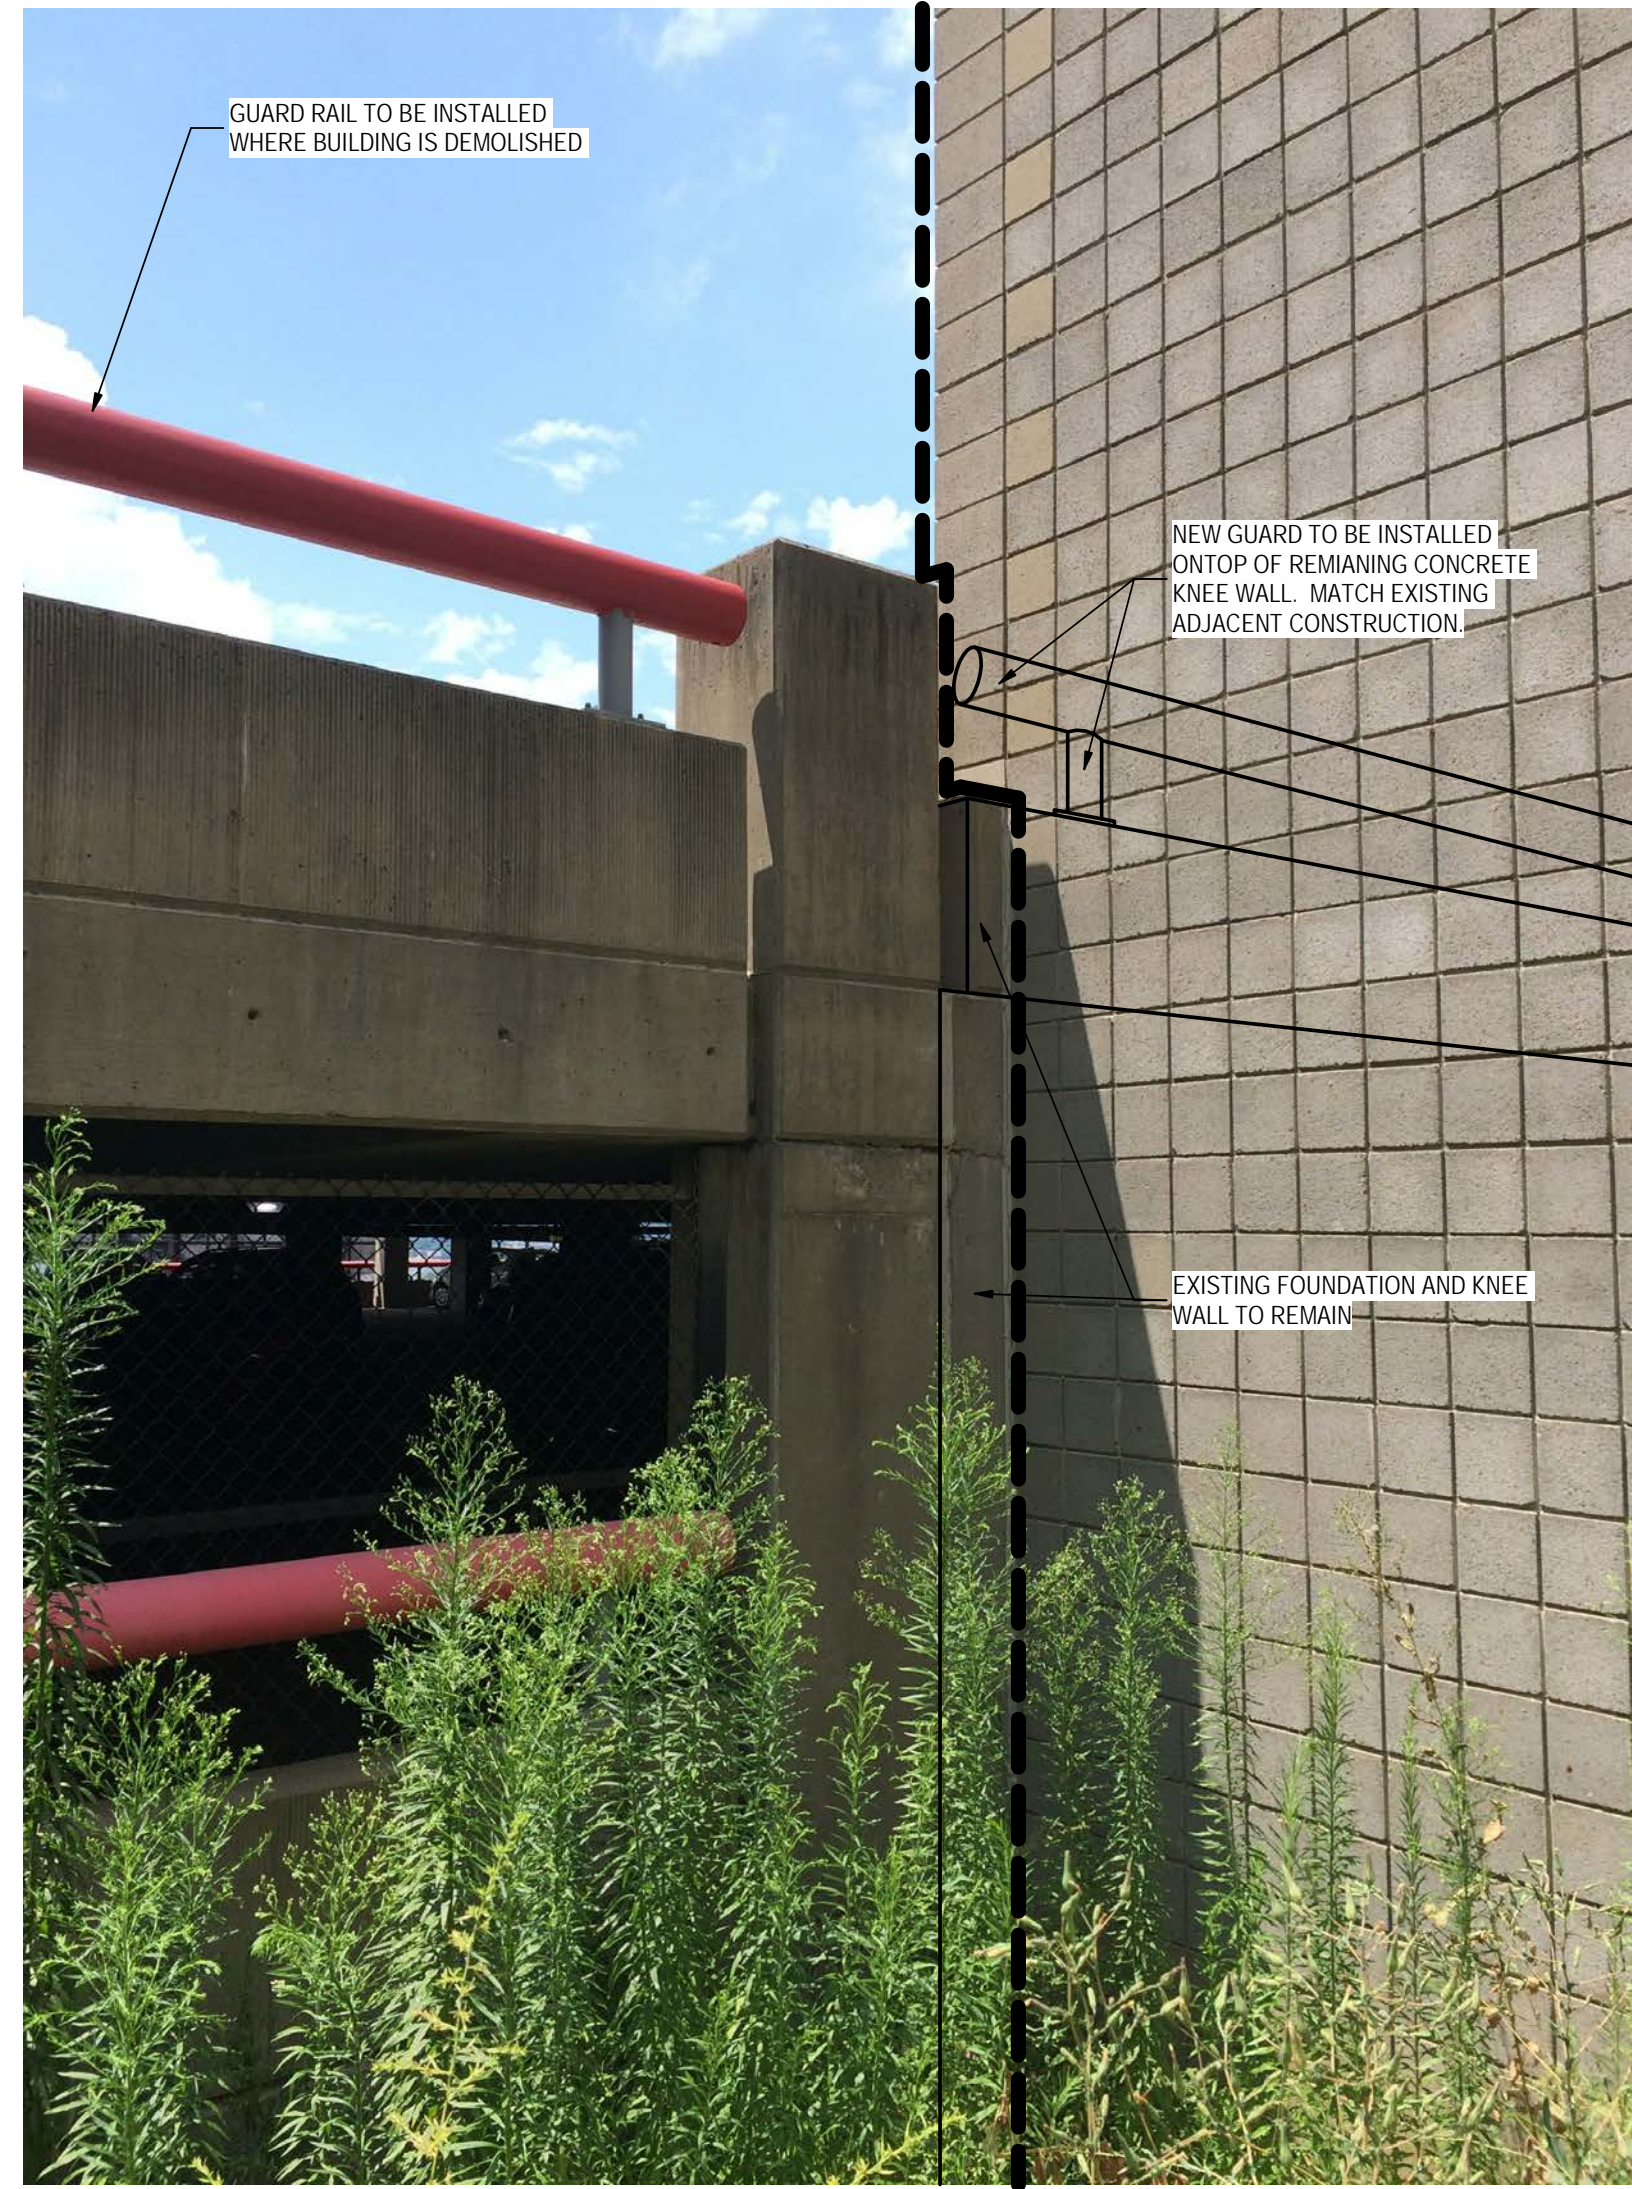

2 VIEW OF GUARD RAIL
 A105 1/4" = 1'-0"

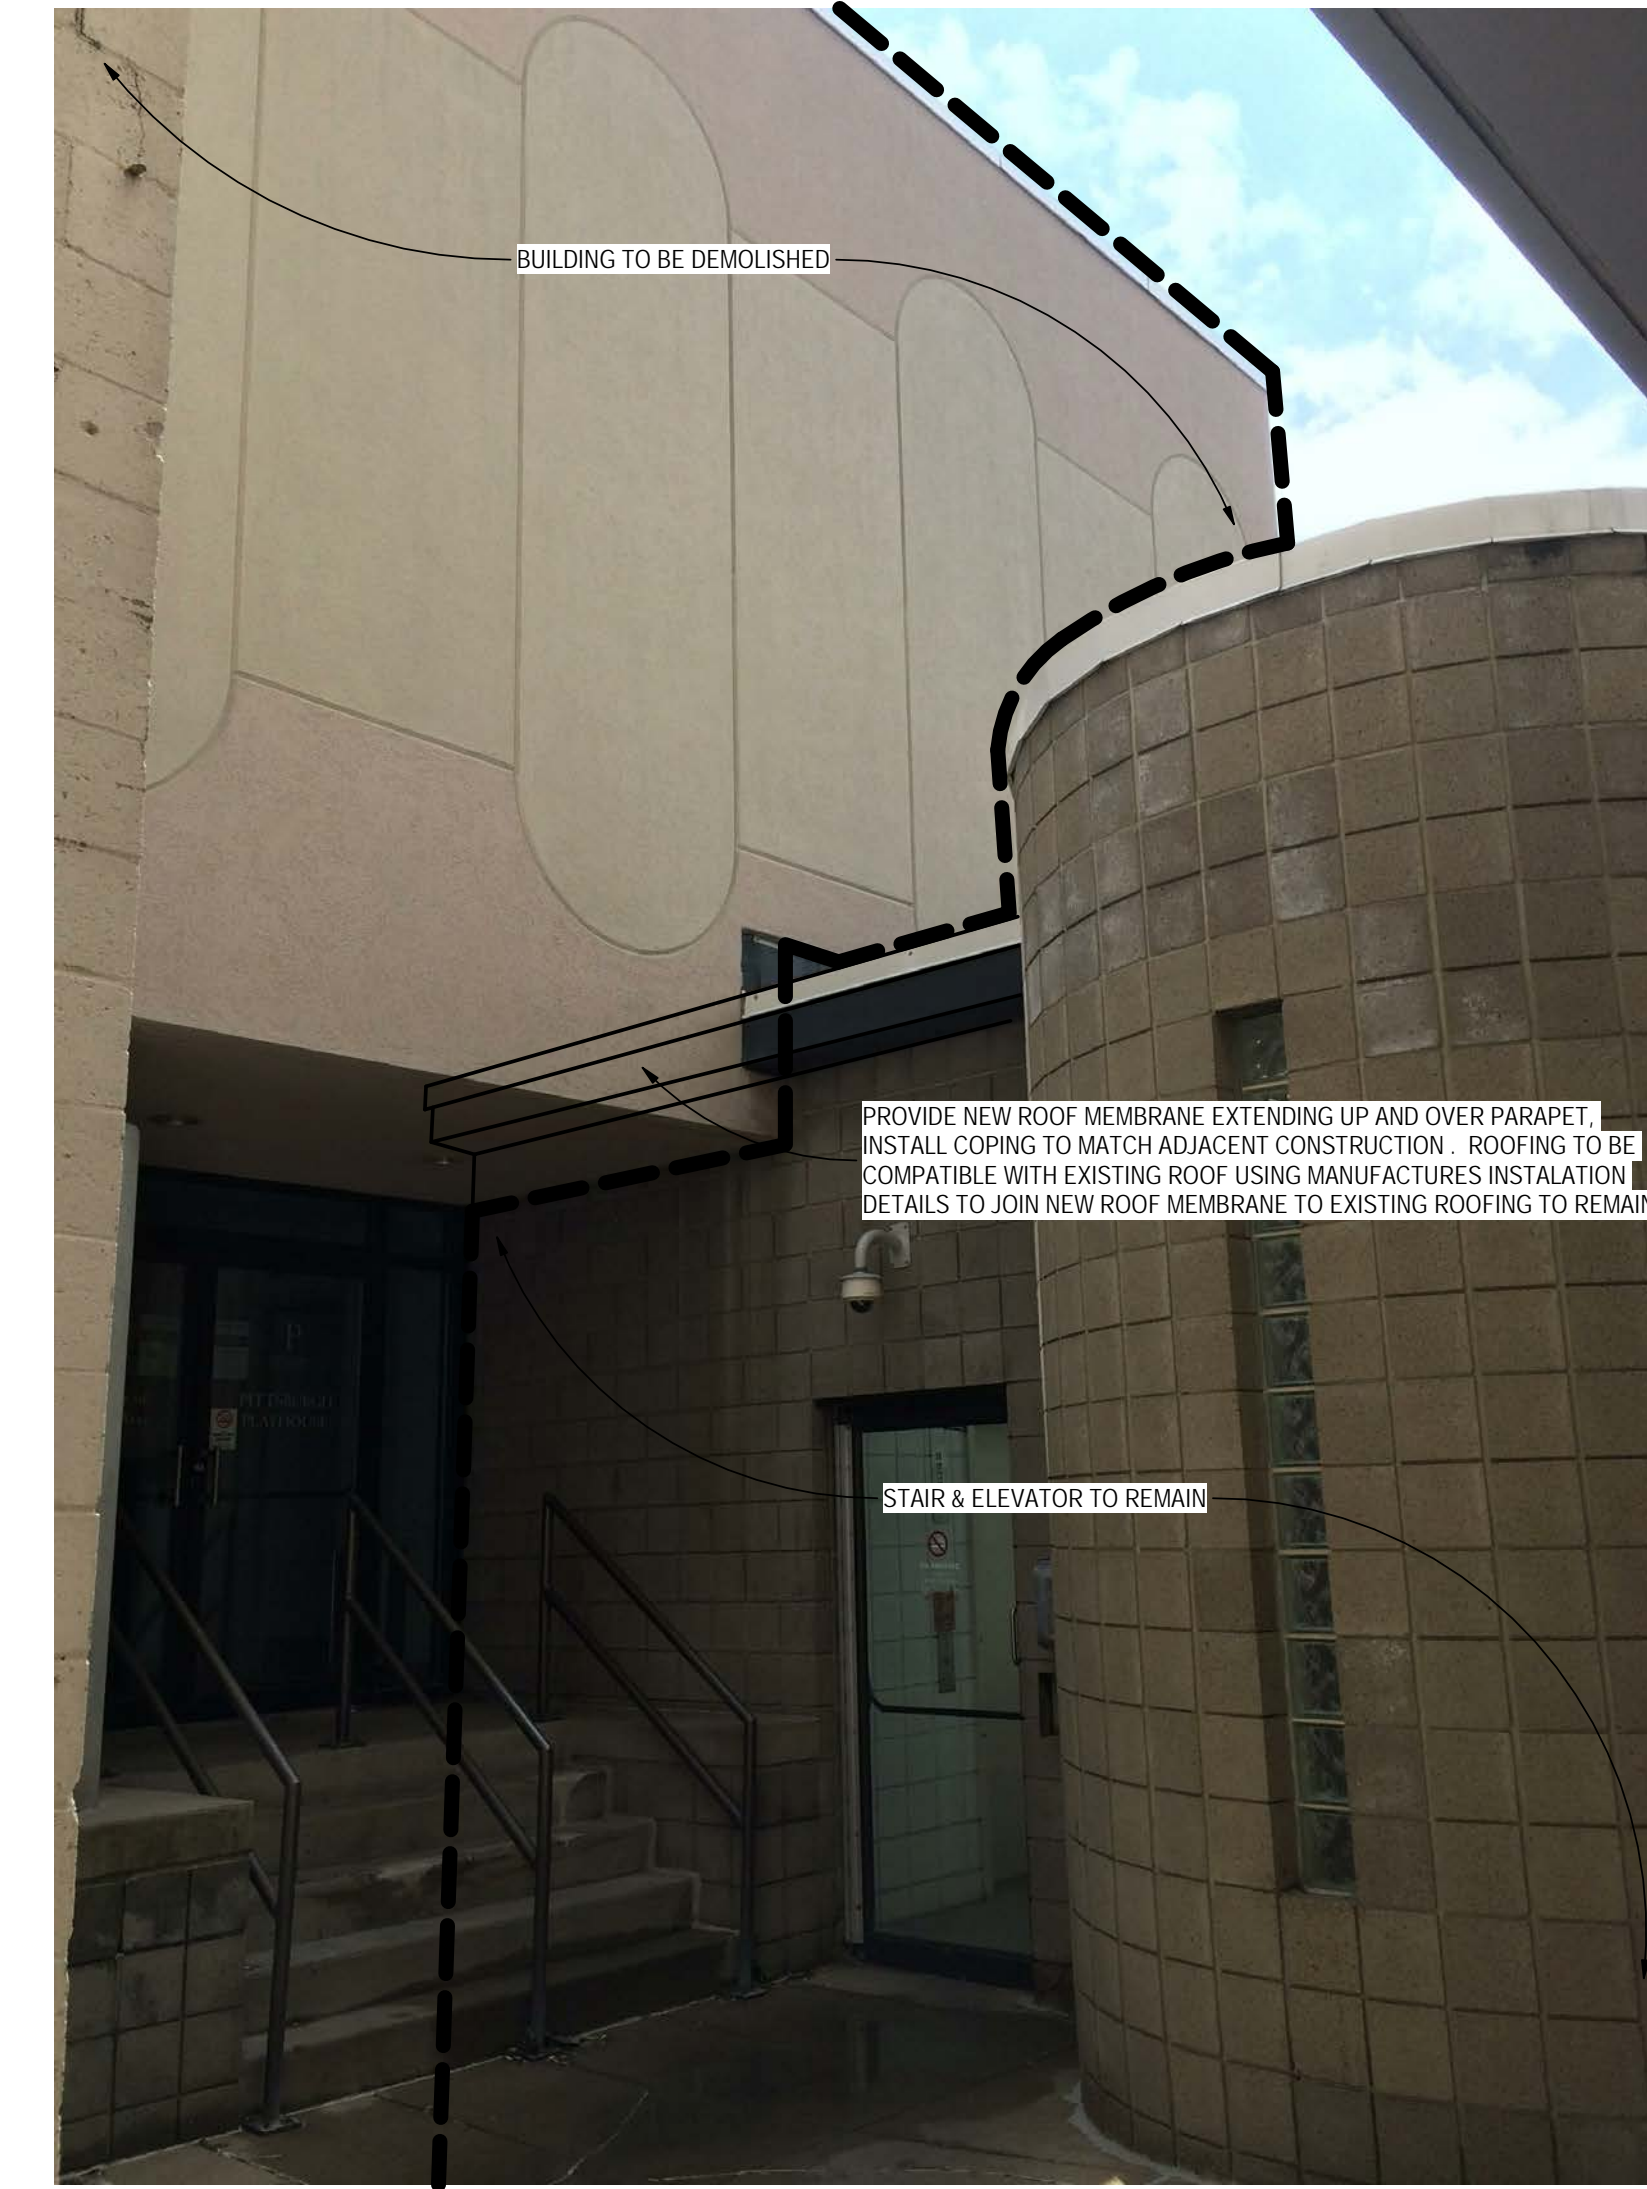

3 VIEW OF ELEVATOR LOBBY
 A105 1/4" = 1'-0"

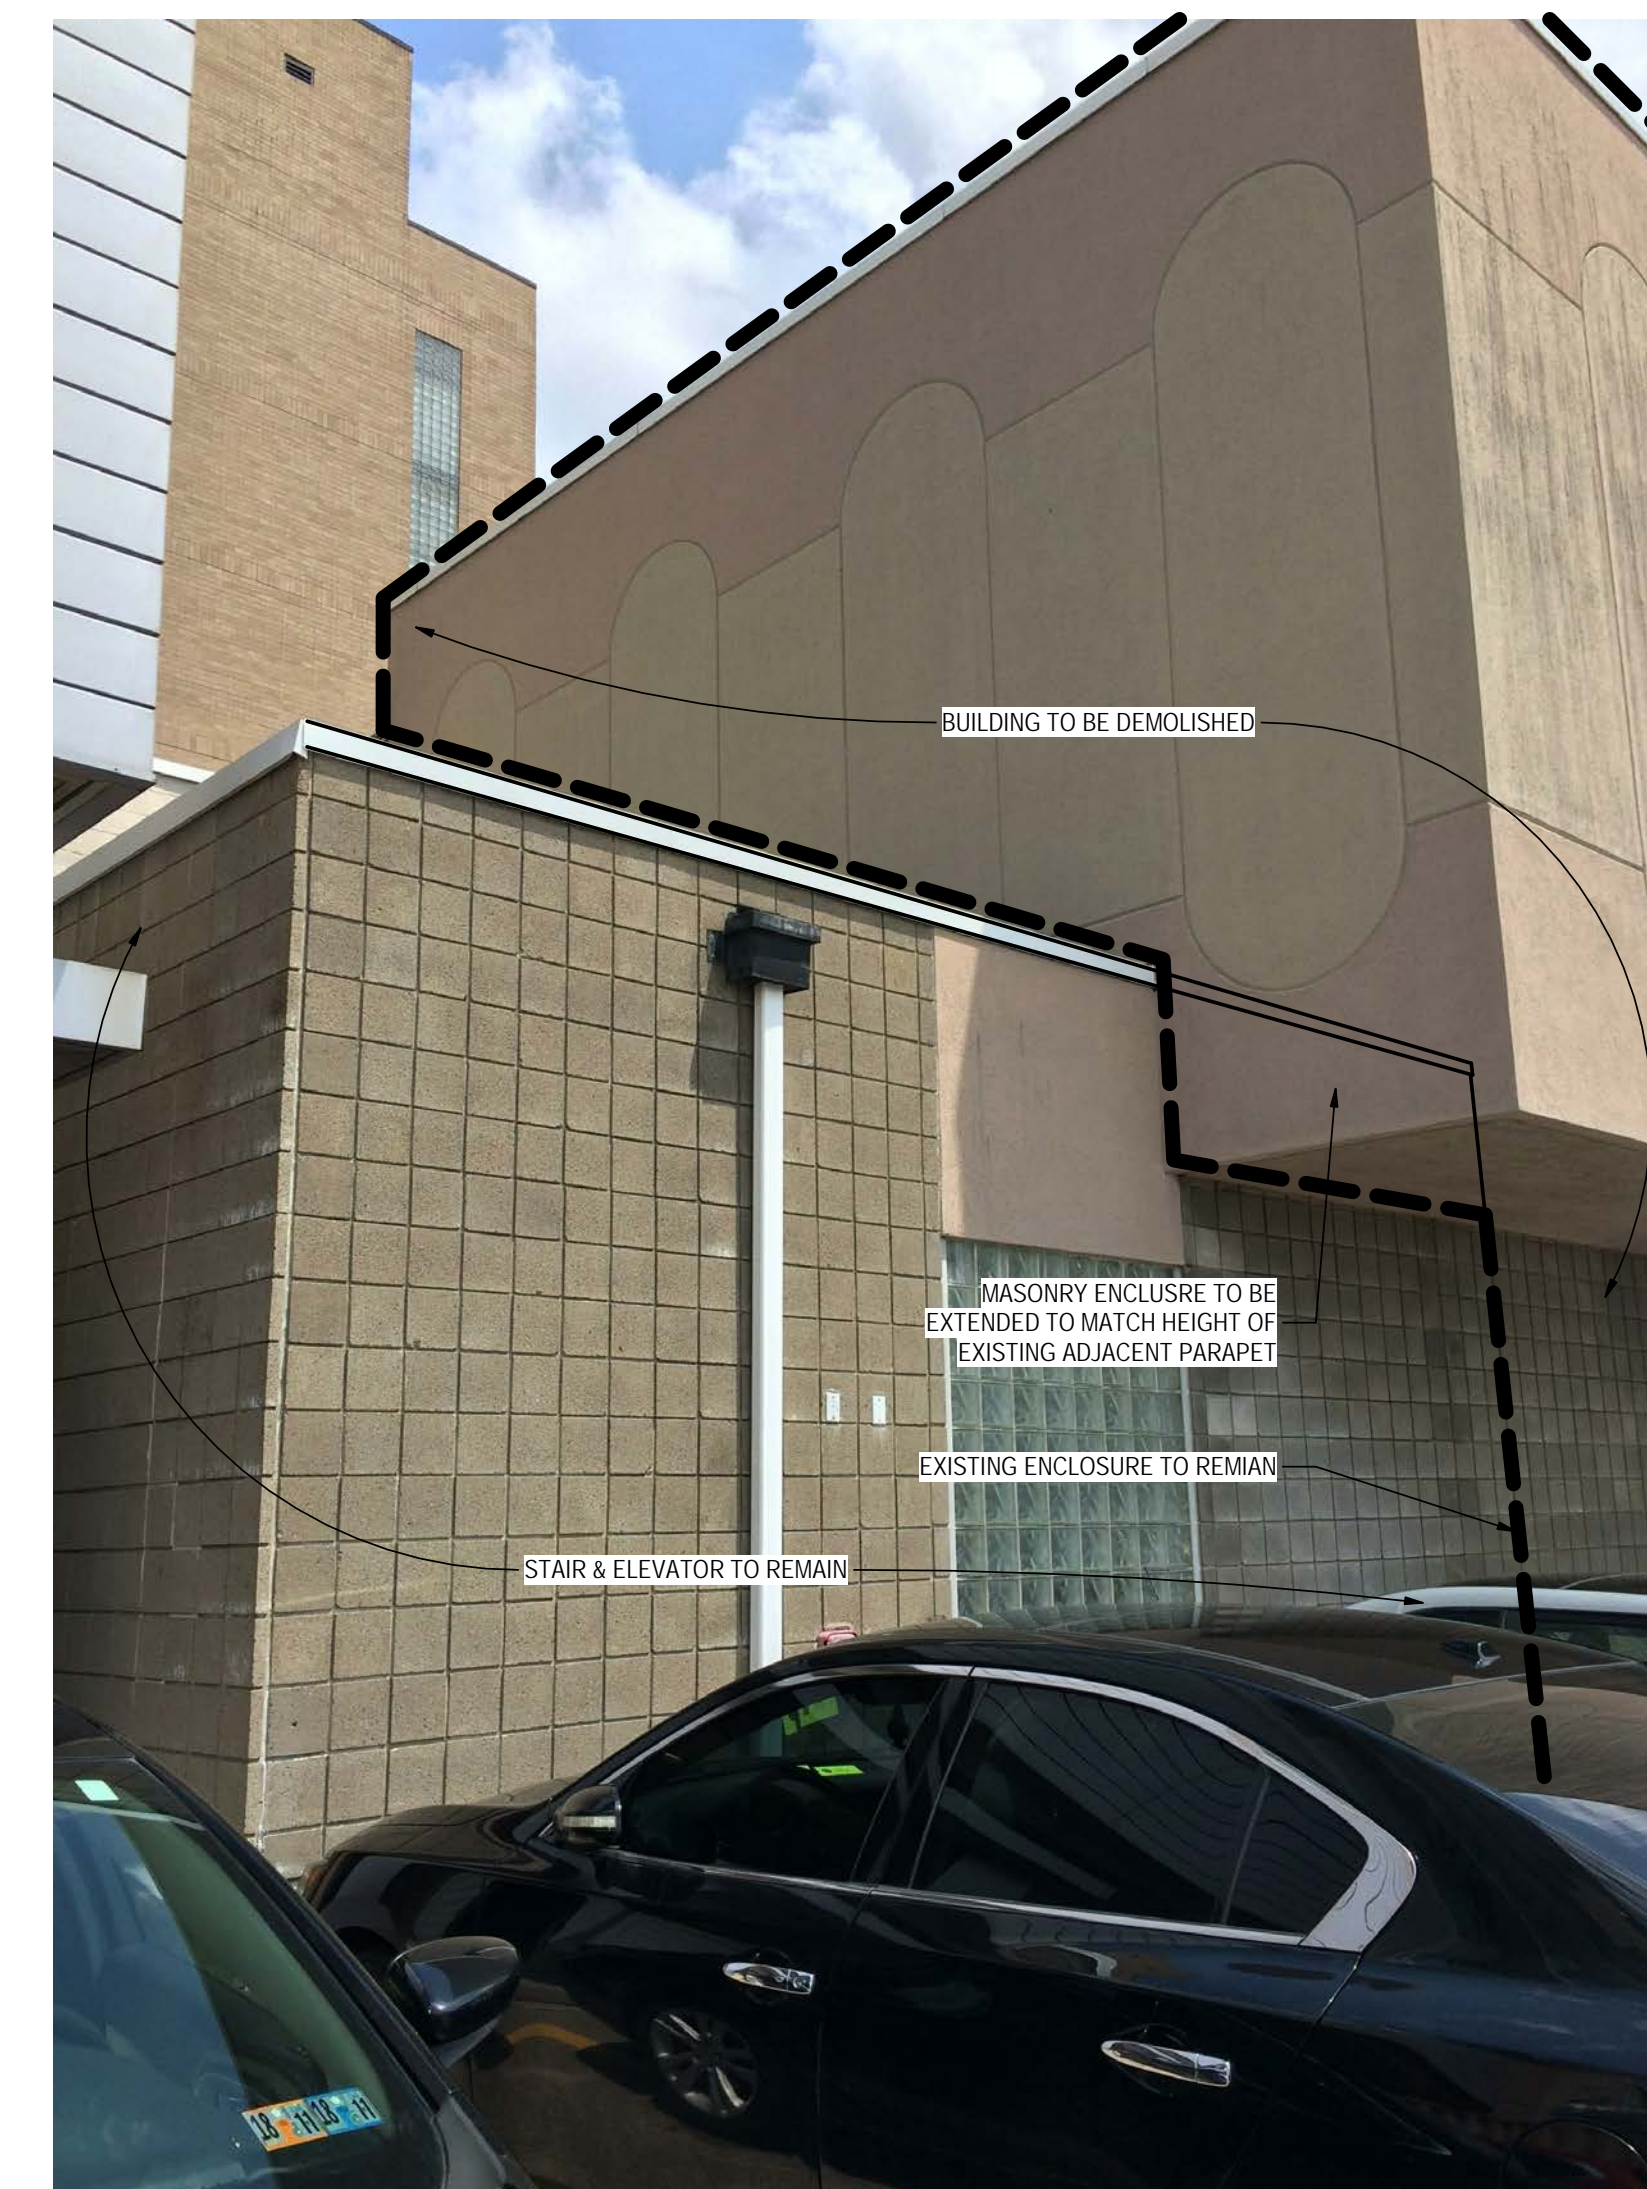

4 STAIR & ELEVATOR ENCLOSURE
 A105 1/4" = 1'-0"

Revision	By	Appd	YYYY-MM-DD
PACKAGE G			
PACKAGE F			
PACKAGE E			
PACKAGE D			
PACKAGE C			
PACKAGE B			
PACKAGE A			
Issued			

File Name	Author	Designer	Checker	DATE
Dwn	Dgn	Chkd	YYYY-MM-DD	

Permit/Seal

**PRELIMINARY
 NOT FOR
 CONSTRUCTION**
 Not for permits, pricing or other official purposes. This document has not been completed or checked and is for general information or comment only.

Client/Project Logo



Client/Project
 Point Park University

PLAYHOUSE DEMOLITION


222 Craft Ave, Pittsburgh PA 15213

Title
 PHOTO REFERENCE

Project No. 218011316
 Revision

Scale 1/4" = 1'-0"
 Drawing No.


A105

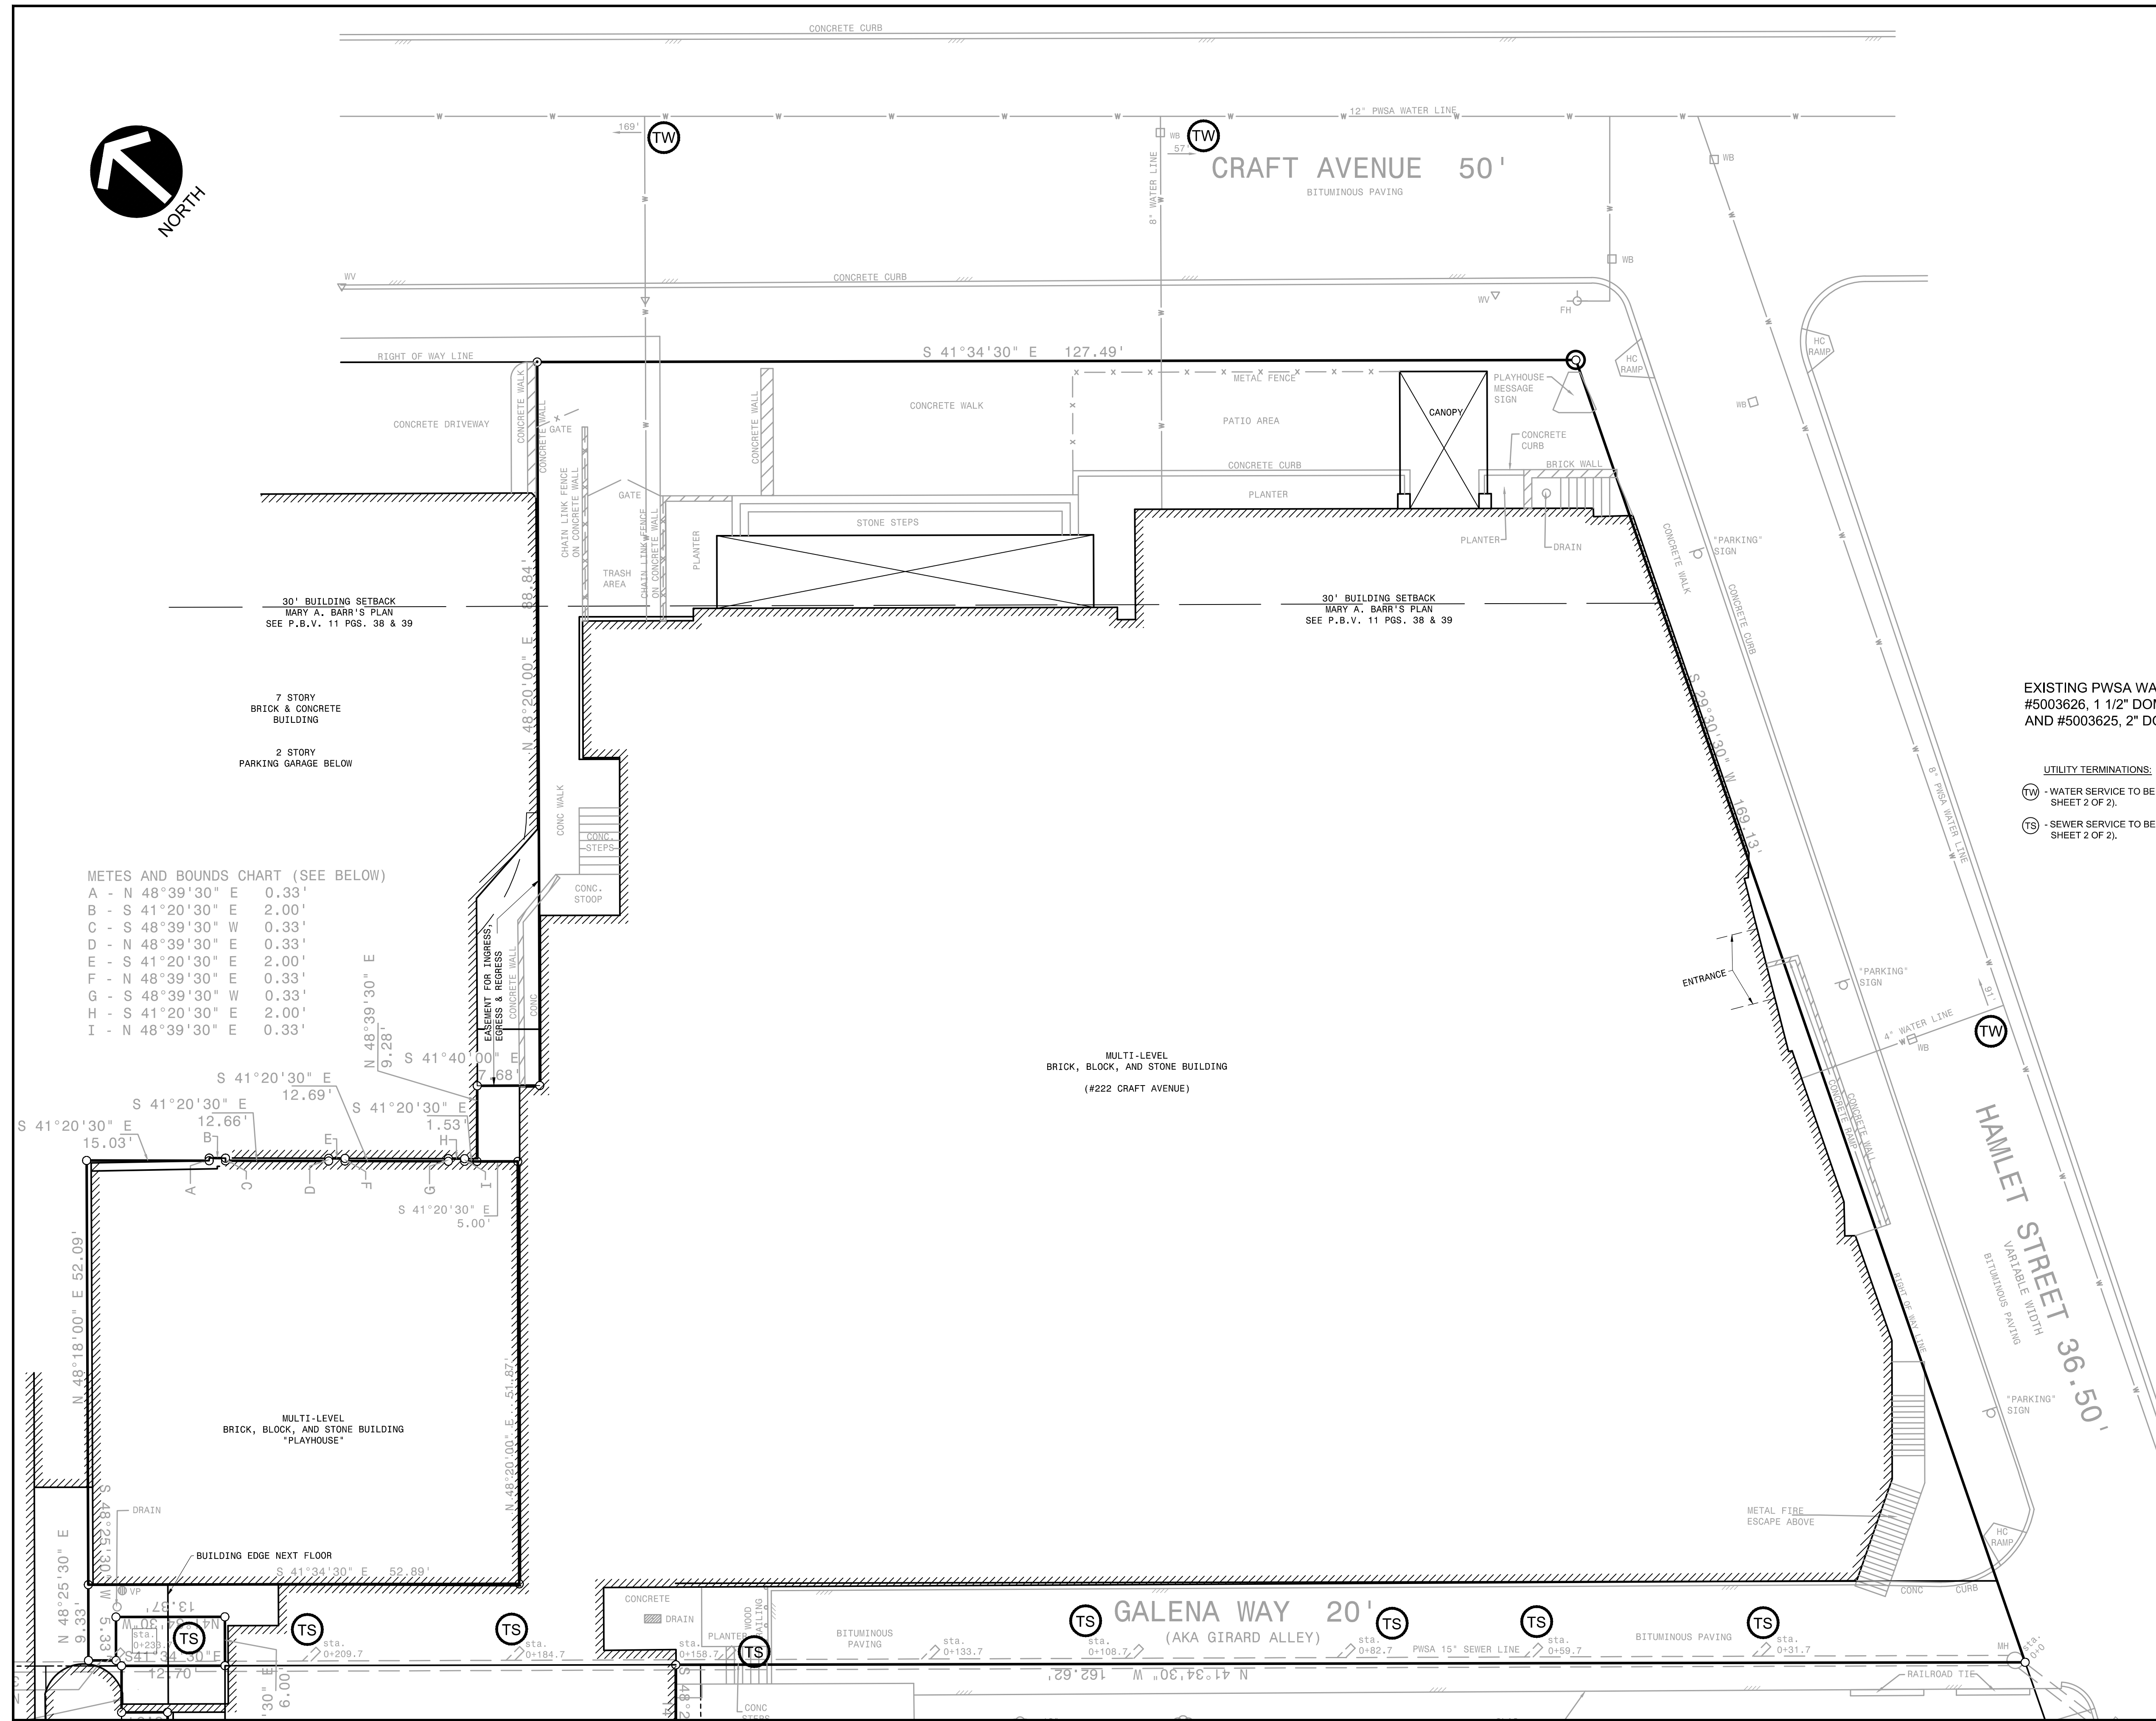

METES AND BOUNDS CHART (SEE BELOW)

A	-	N 48°39'30" E	0.33'
B	-	S 41°20'30" E	2.00'
C	-	S 48°39'30" W	0.33'
D	-	N 48°39'30" E	0.33'
E	-	S 41°20'30" E	2.00'
F	-	N 48°39'30" E	0.33'
G	-	S 48°39'30" W	0.33'
H	-	S 41°20'30" E	2.00'
I	-	N 48°39'30" E	0.33'

EXISTING PWSA WATER SERVICE ACCOUNTS:
 #5003626, 1 1/2" DOMESTIC METER #60984457
 AND #5003625, 2" DOMESTIC METER #60969135

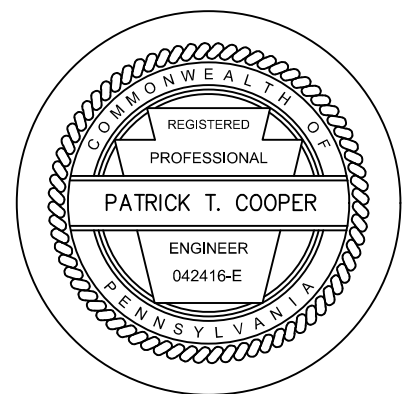

- UTILITY TERMINATIONS:
- WATER SERVICE TO BE TERMINATED (REFER TO DETAIL, SHEET 2 OF 2).
 - SEWER SERVICE TO BE TERMINATED (REFER TO DETAIL, SHEET 2 OF 2).

ENGINEER

THE PITTSBURGH WATER AND SEWER AUTHORITY

APPROVAL FOR:

- NEW WATER TAP, BACKFLOW PREVENTOR, AND METER INSTALLATION
- NEW SANITARY AND/OR STORM SEWER TAP
- INCREASE IN FLOW AT EXISTING SEWER AND/OR WATER CONNECTION
- SEWER TAP TERMINATION
- WATER TAP TERMINATION

*DISCLAIMER:
 Signatures/Approval by PWSA are for the physical connection(s) to the water and/or sewer system only. Responsibility for the design and work depicted by the drawings, including the flow design for the facilities, is by the Professional Engineer shown by the seal and signature affixed to the drawing. The PWSA does not represent or warrant that the water supply to the facilities is sufficient to support the design.

Project Coordinator/Project Management Engineer/Reviewer certifies that he/she has reviewed the above noted document(s) in accordance with the Authority's established rules and regulations. Based on the review, approval is hereby recommended.

 Project Coordinator/Project Management Engineer/Reviewer

 Approval

 Manager of Development Services

 Director of Field Services

Date _____
 Date _____

OAKLAND - PITTSBURGH PLAYHOUSE

WATER AND SEWER TAP TERMINATION PLANS

222 CRAFT AVENUE
 4th WARD, CITY OF PITTSBURGH, 15213

SCALE: 1"= 10'
 DATE: SEPTEMBER, 2018

SHEET NO. 1 OF 2
 ACCESSION NO. _____
 CASE NO. _____



P:\p\p\Projects\3000030001 Playhouse Demo\DWG\PWSA Plans.dwg
 Save Date: 9/15/2018 3:07 PM
 User: Robert W. Malt, Jr.